



PANDA EXPRESS, INC.
1683 Walnut Grove Ave.
Rosemead, California
91770
Telephone: 626.799.9898
Facsimile: 626.372.8288

All ideas, designs, arrangement and plans indicated or represented by this drawing are the property of Panda Express Inc. and were created for use on this specific project. None of these ideas, designs, arrangements or plans may be used by or disclosed to any person, firm, or corporation without the written permission of Panda Express Inc.

REVISIONS:		

ISSUE DATE:		
1st	PERMIT	12-22-17
2nd	BID	02-02-18

DRAWN BY: VTL	
PANDA PROJECT #:	S8-19-5806
ARCH PROJECT #:	17044.032

hckloverarchitect
10955 LOWELL AVENUE, SUITE 700
OVERLAND PARK, KS 66210
ph: 913.649.8181 • fx: 913.649.1275

PANDA EXPRESS
OLD LEE HWY & LITTLE DEBBIE PKWY
8967 OLD LEE HIGHWAY
COLLEGE DALE, TN 37363

A-102

ROUGH - IN PLUMBING PLAN

NOT USED

3

NOT USED


2

Scale= 1 1/2" = 1'-0"

A-102

BID SET 02.02.18

TRUE WARM & WELCOME 2200

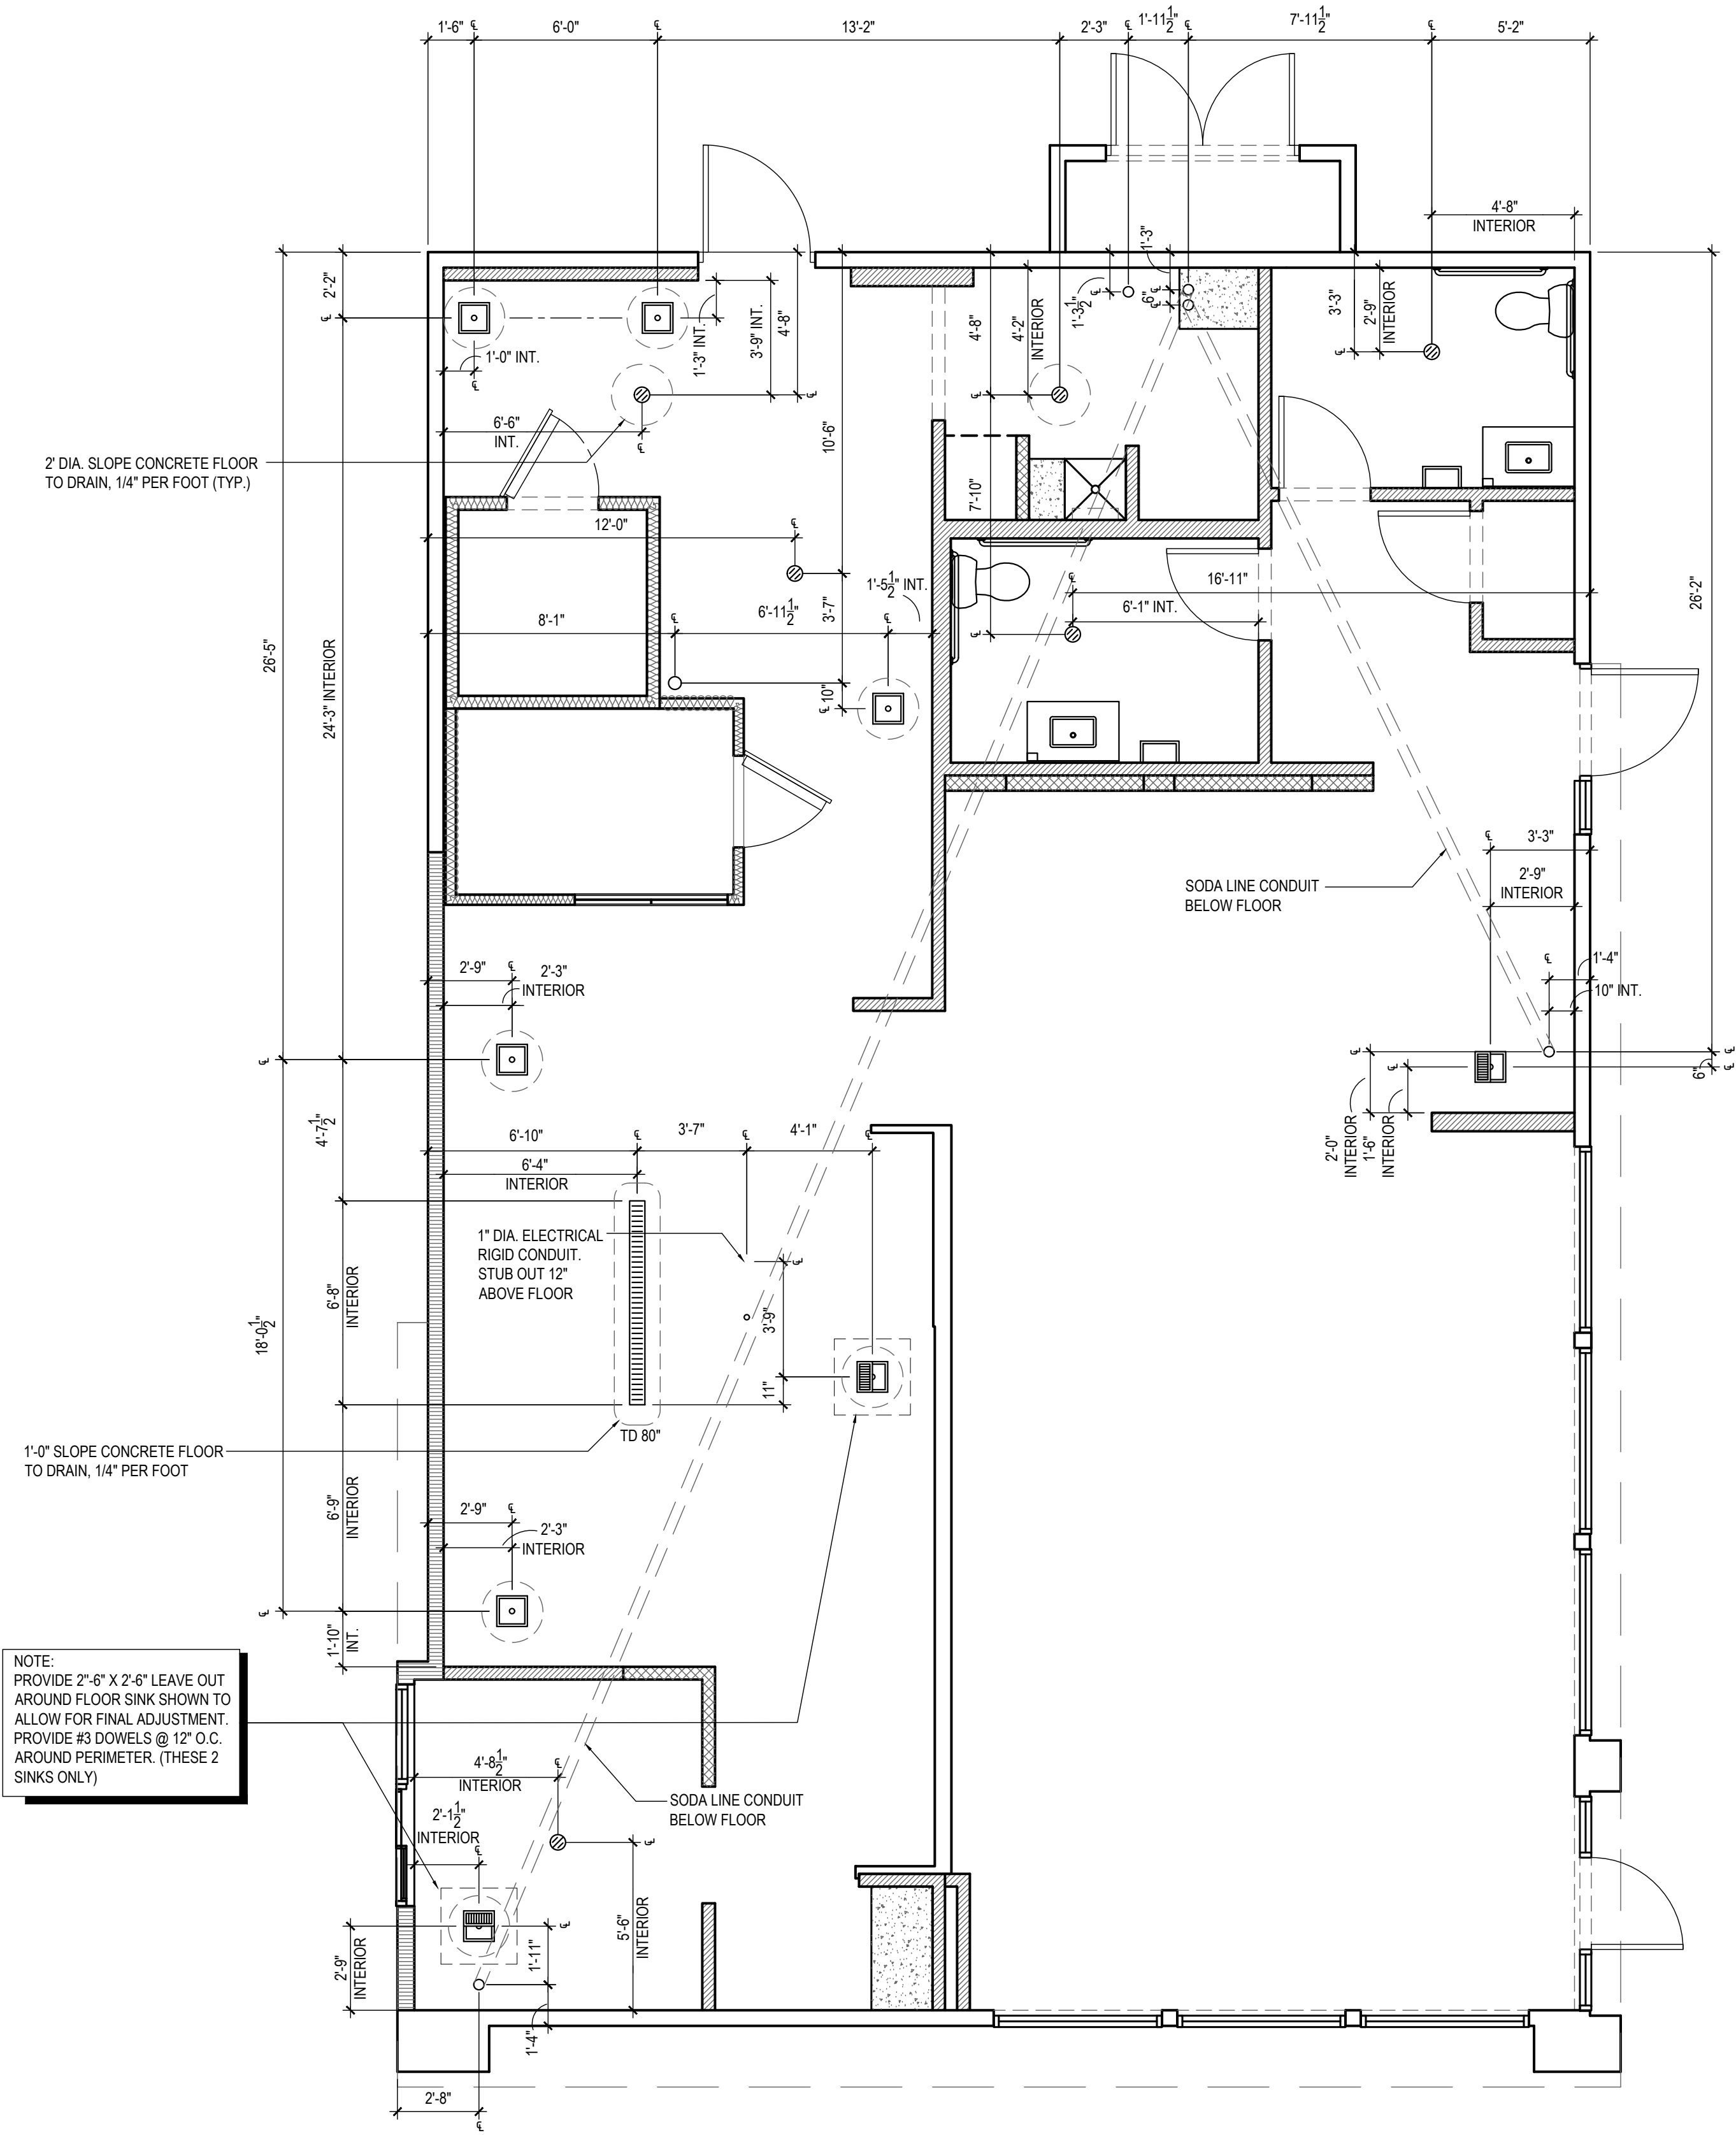

NOT USED	3	NOT USED	2
Scale= 1 1/2" = 1'-0"	A-102	Scale= 1 1/2" = 1'-0"	A-102

ROUGH - IN PLUMBING PLAN	1
Scale= 1/4" = 1'-0"	A-102