


WATER & GAS PIPING PLAN

SCALE: 1/8" = 1'-0"

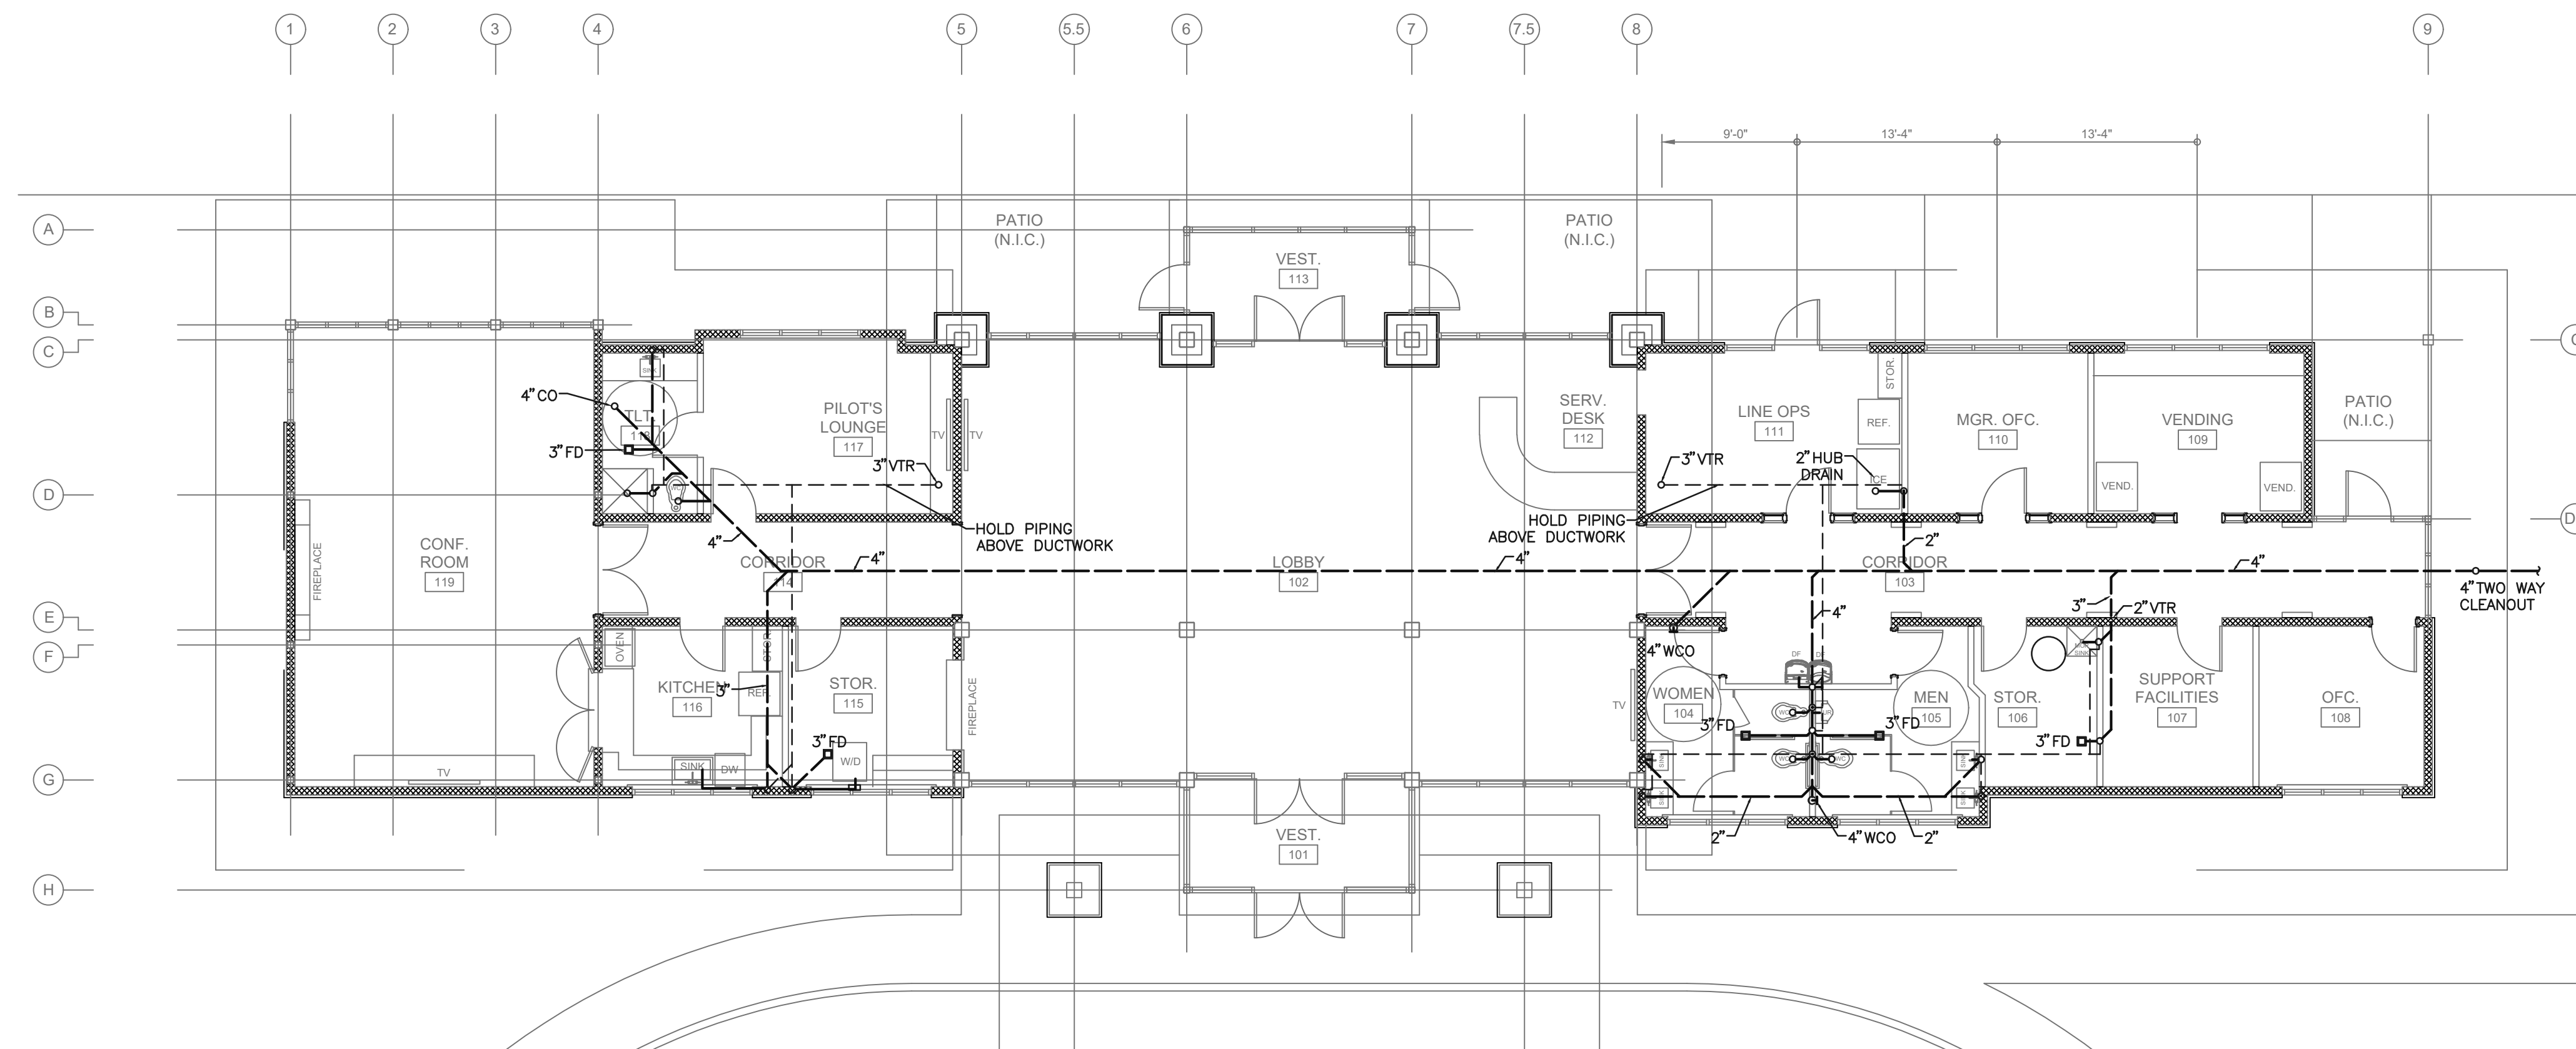

WASTE & VENT PIPING PLAN

SCALE: 1/8" = 1'-0"